


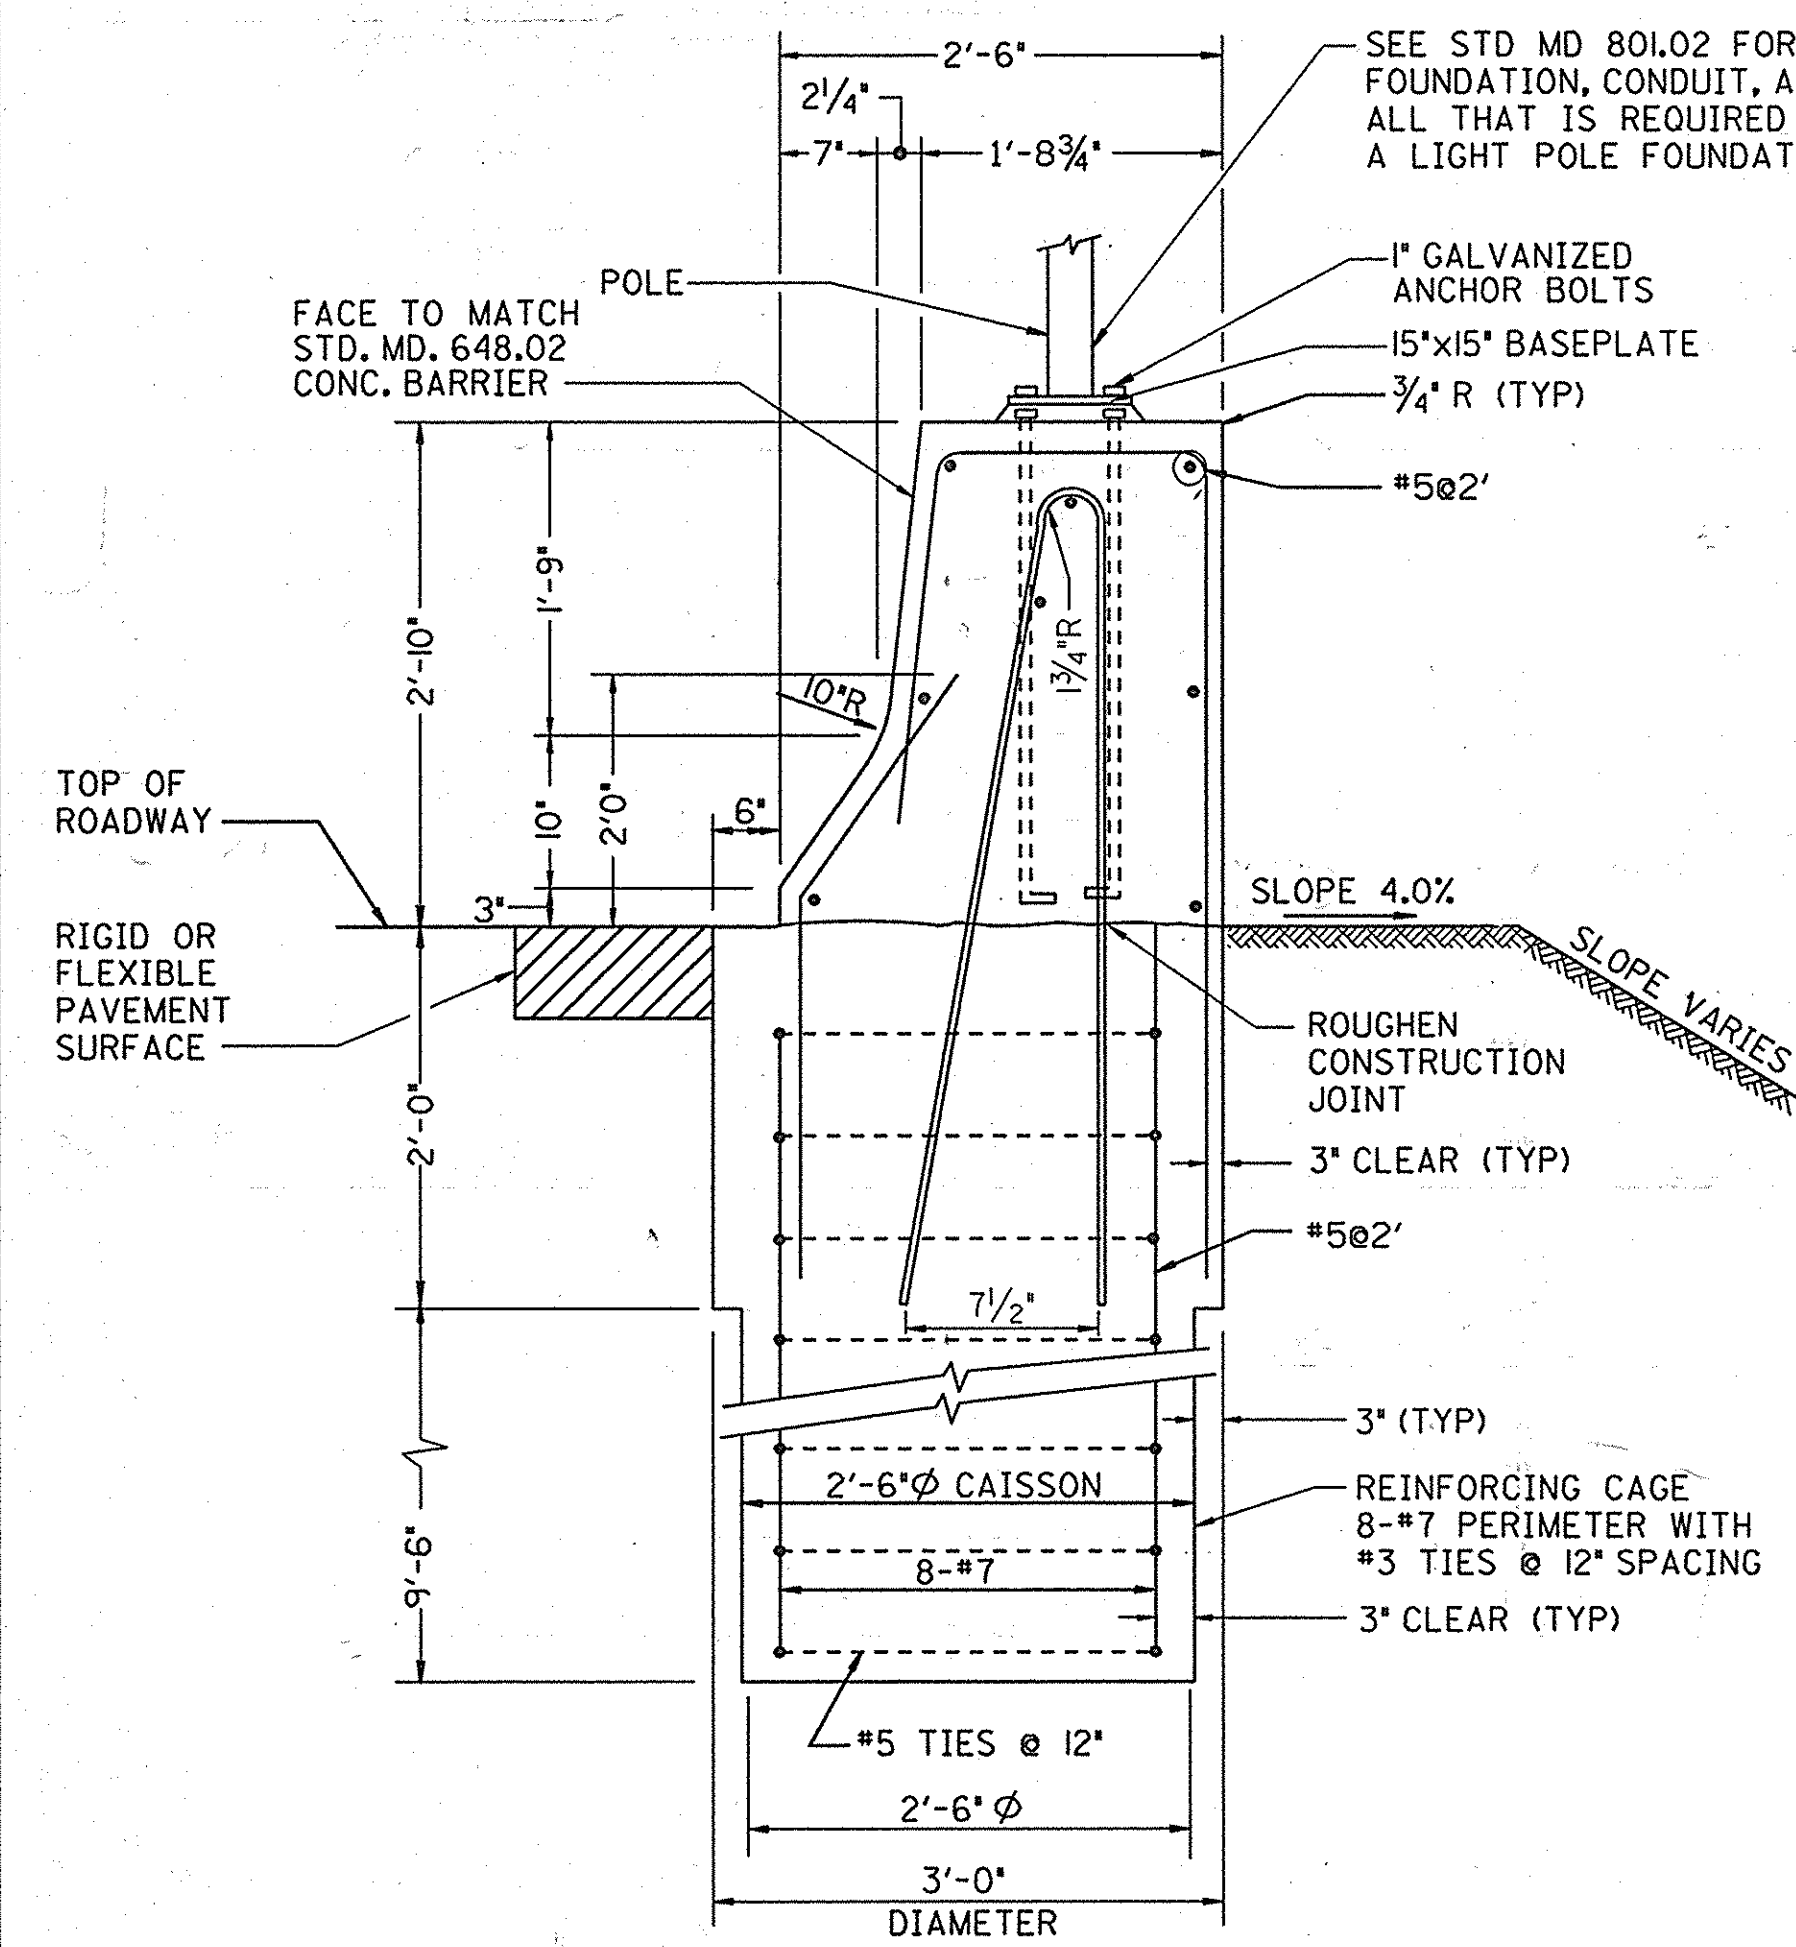


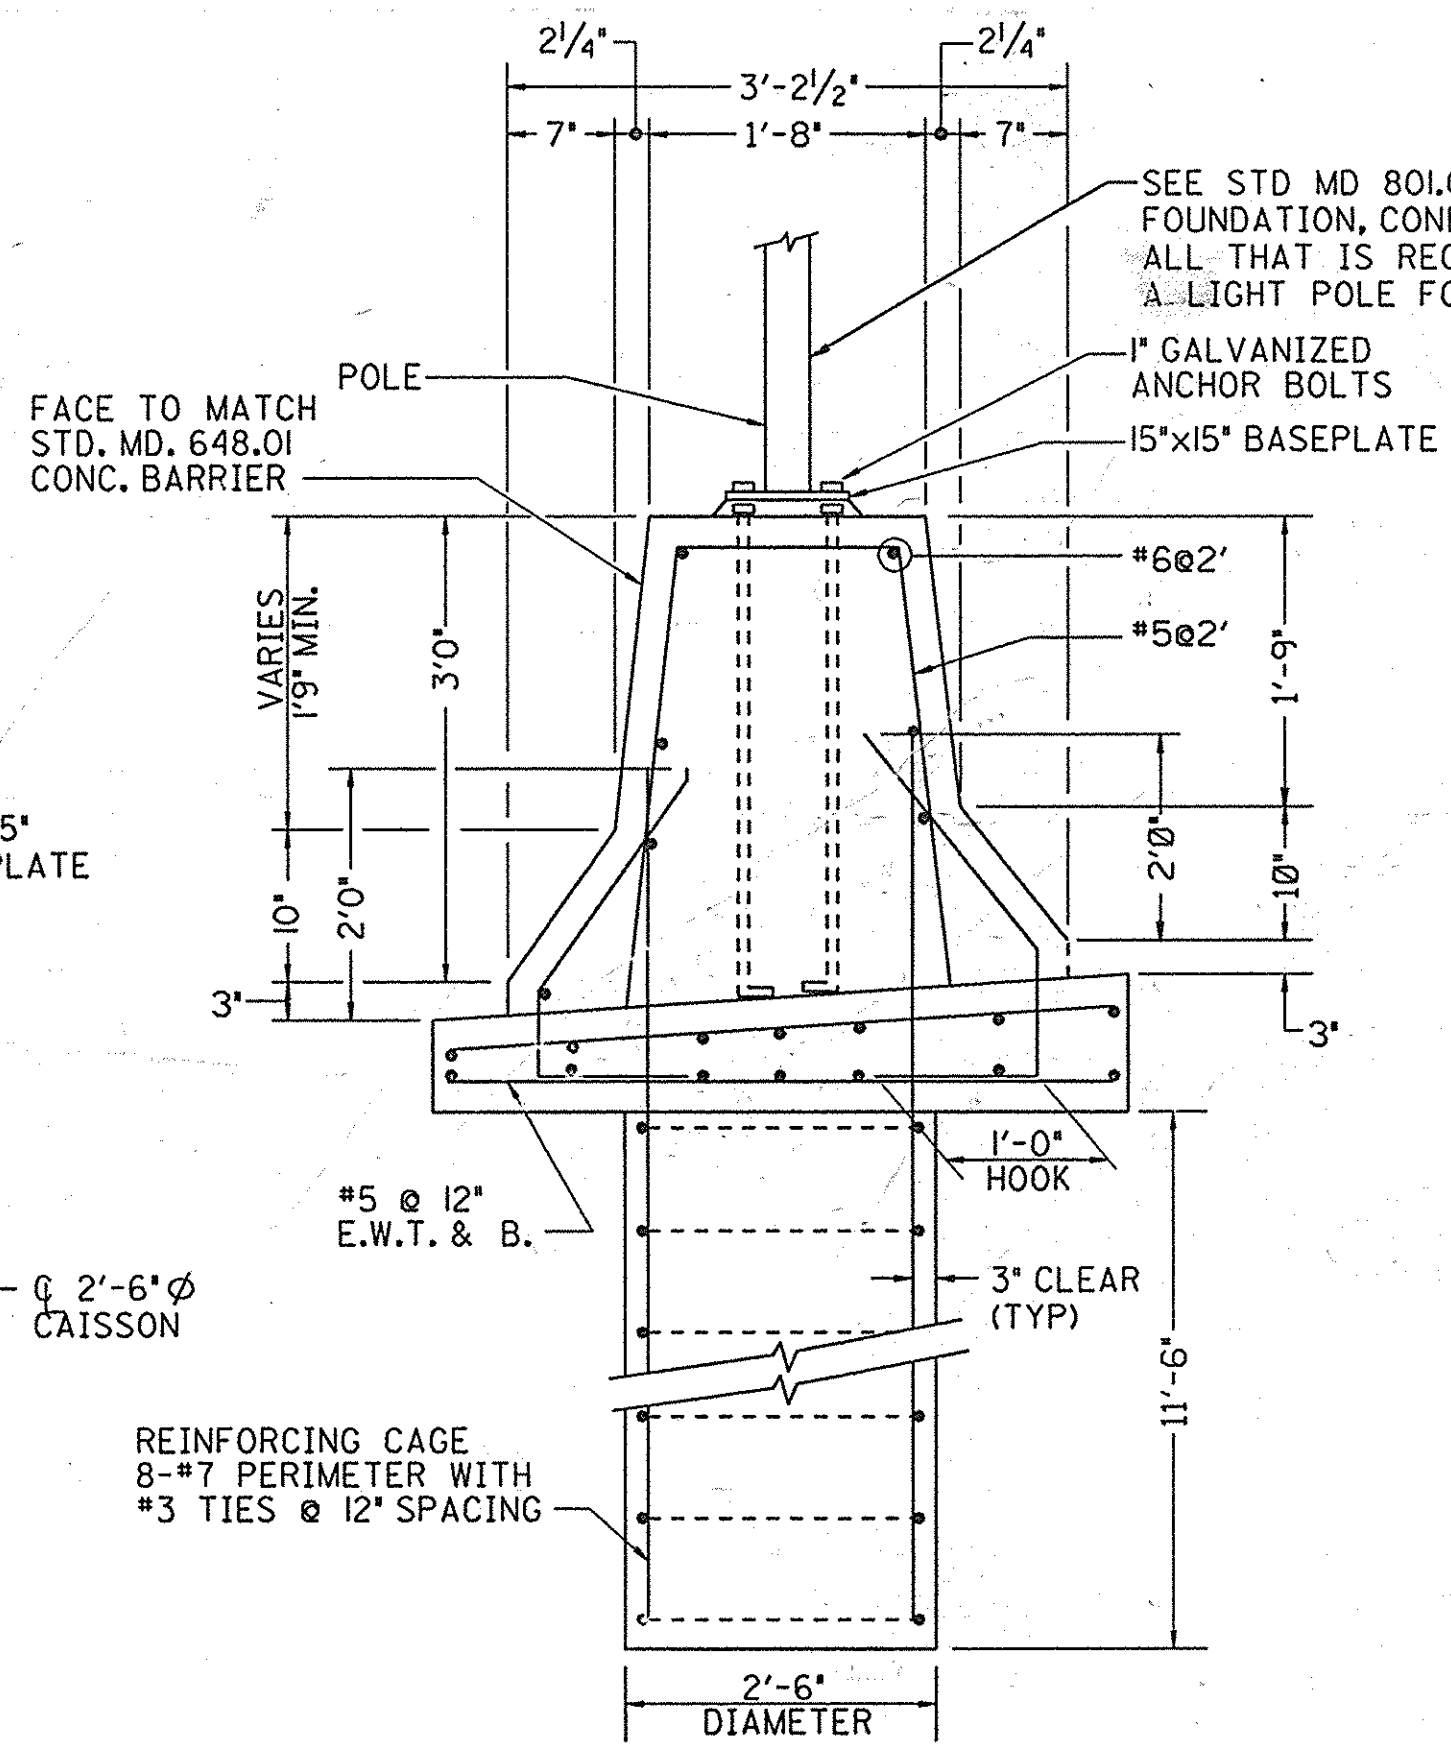


SECTION A-A
LIGHT POLE FOUNDATION @
STANDARD SINGLE FACE TRAFFIC BARRIER
TYPE C
NOT TO SCALE

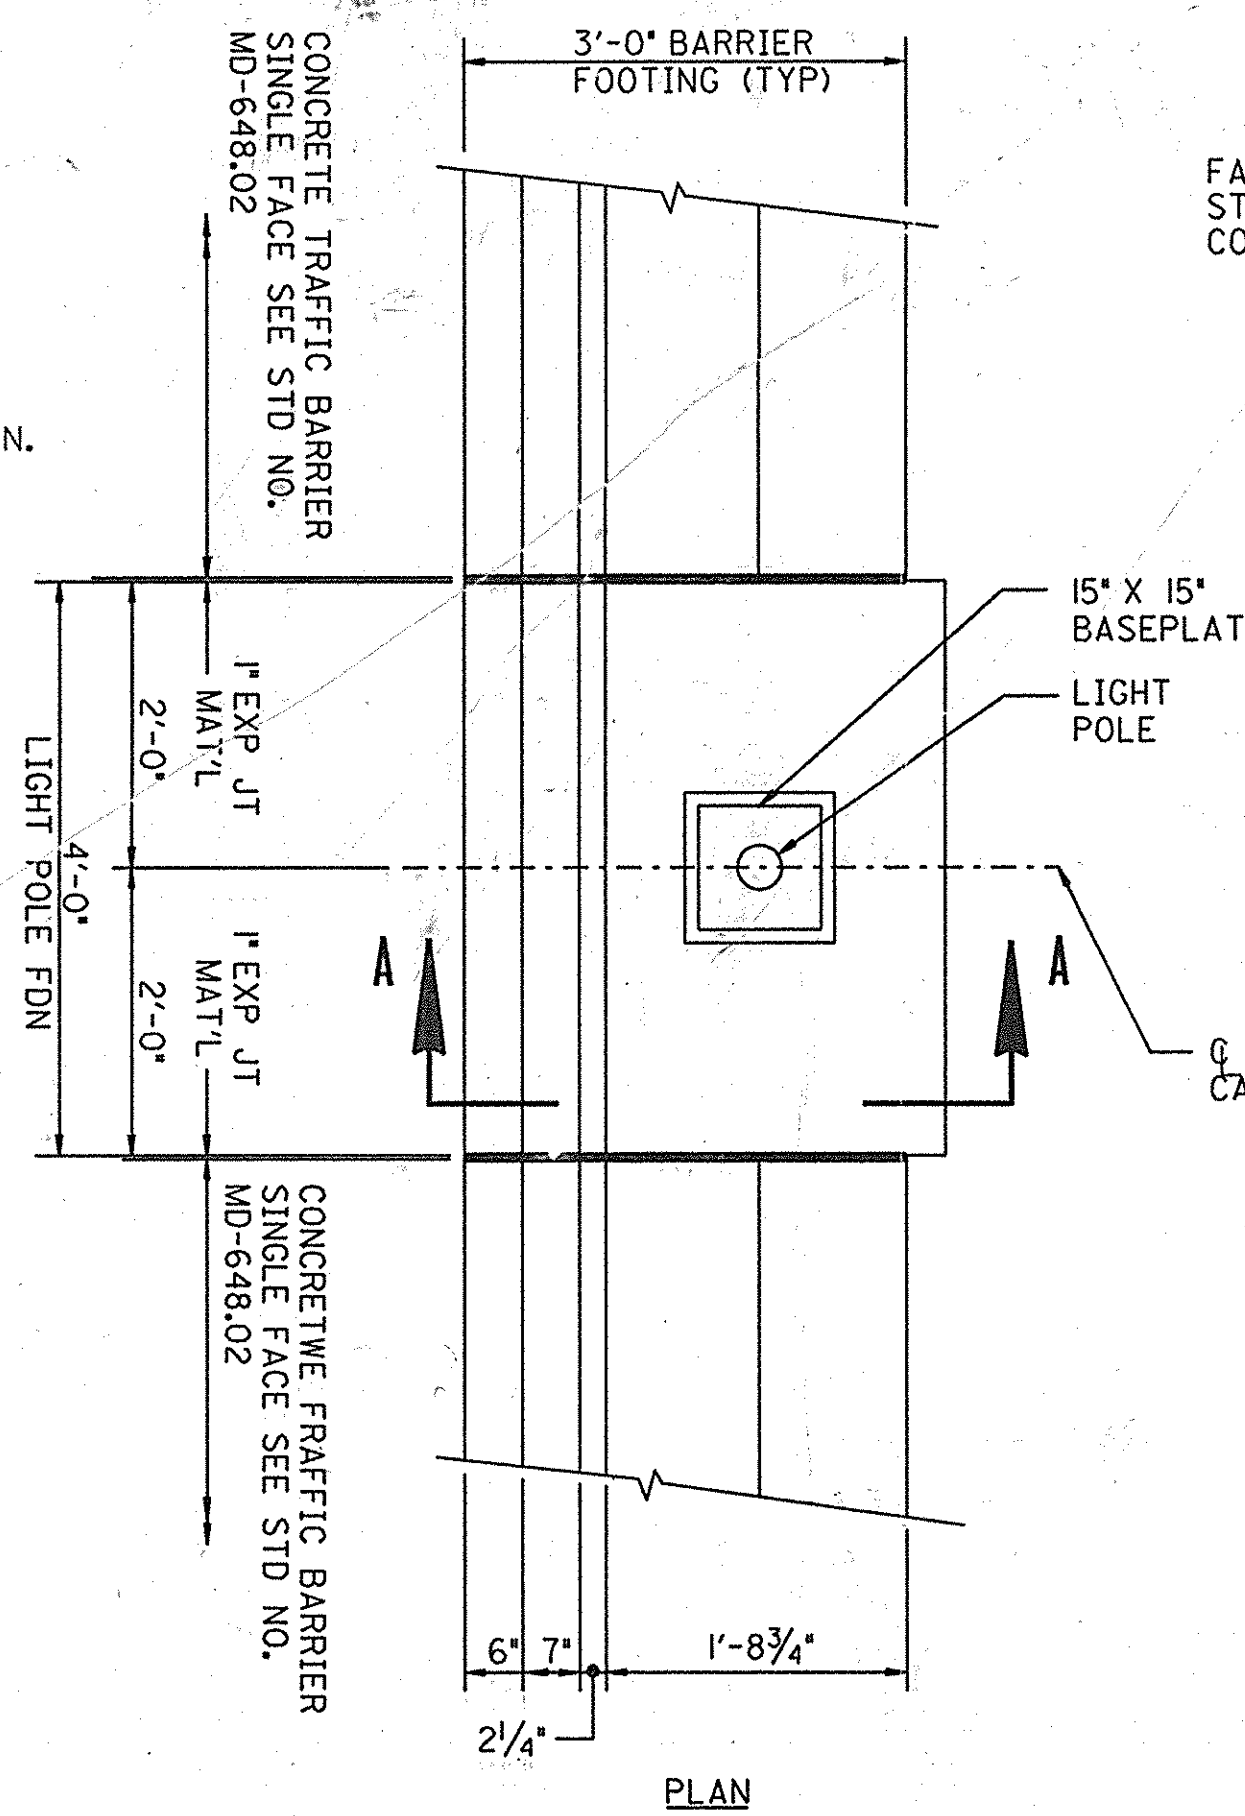


TYPICAL LIGHTING STRUCTURE
FOUNDATION - TYPE J
NOT TO SCALE

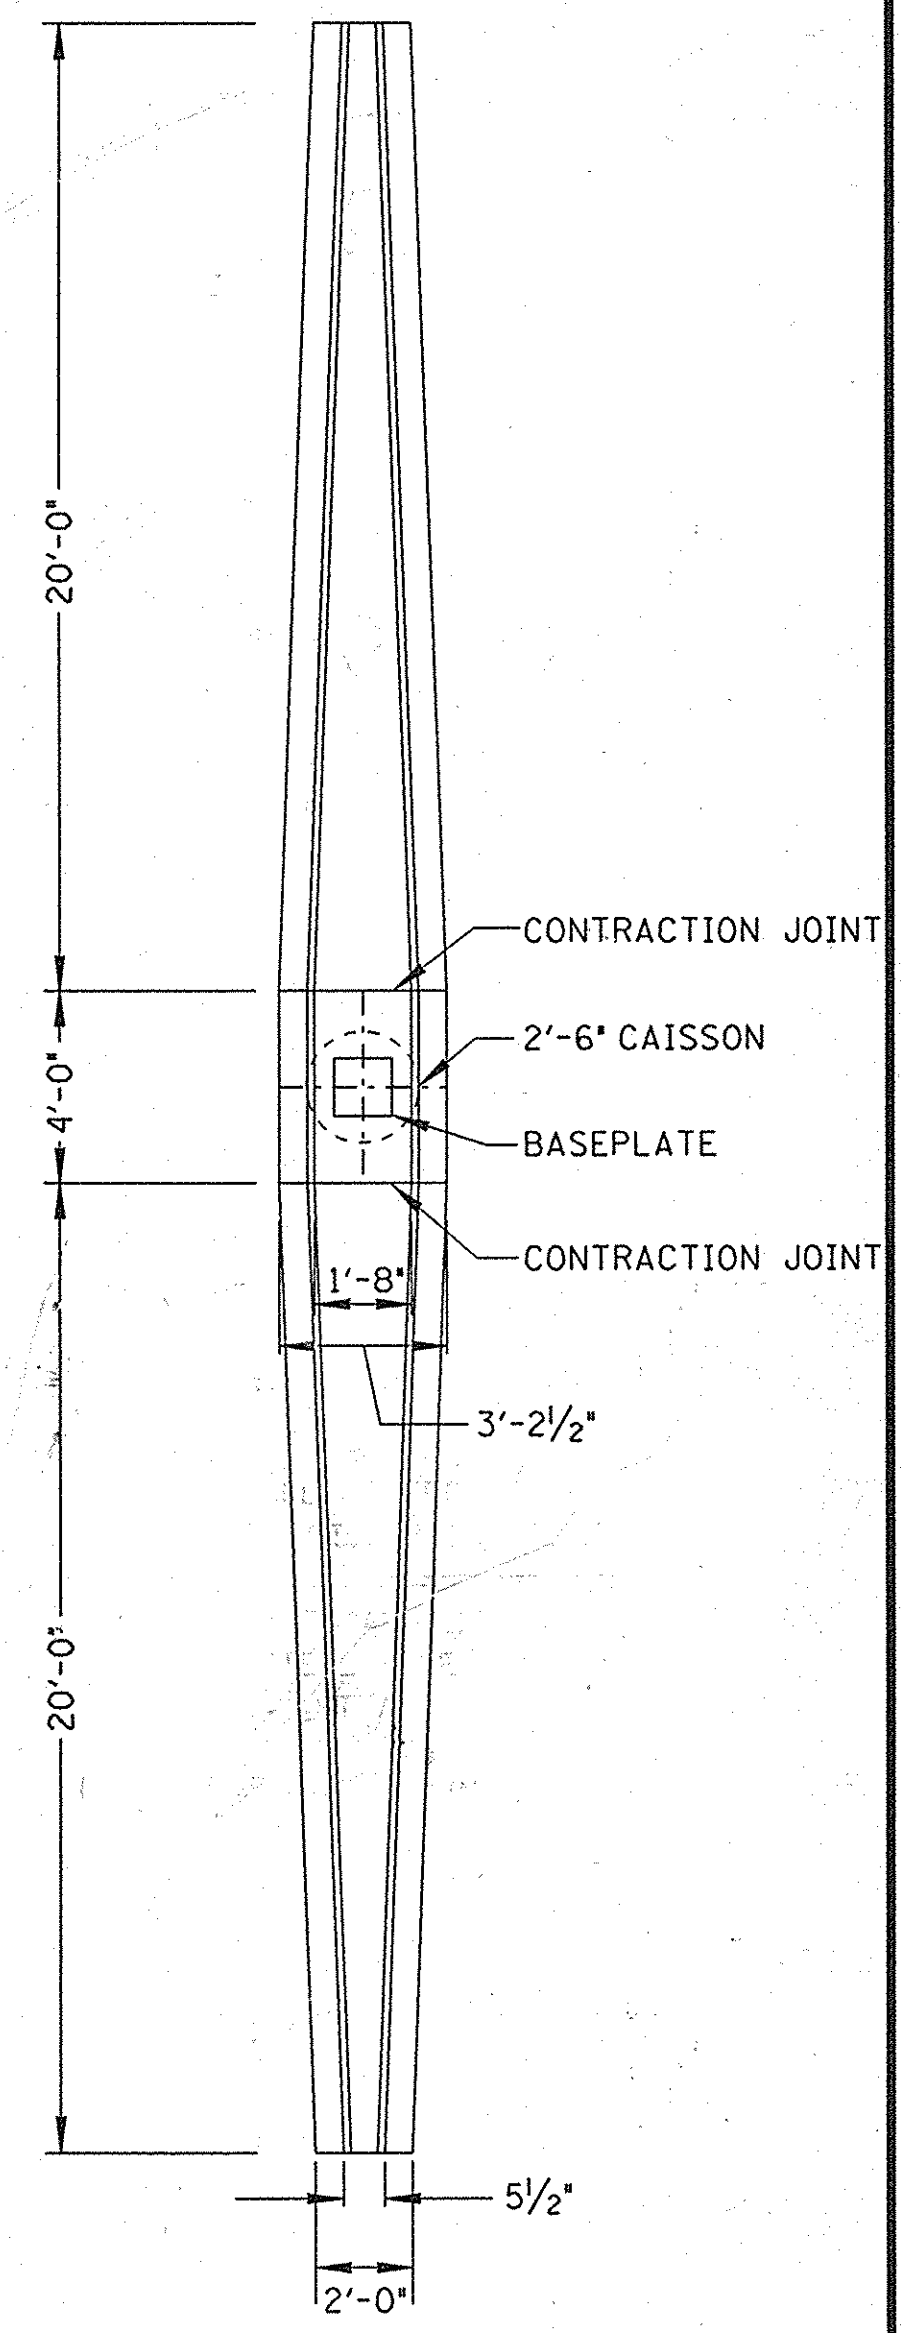


PLAN MEDIAN WIDENING
DETAIL - TYPE J
NOT TO SCALE

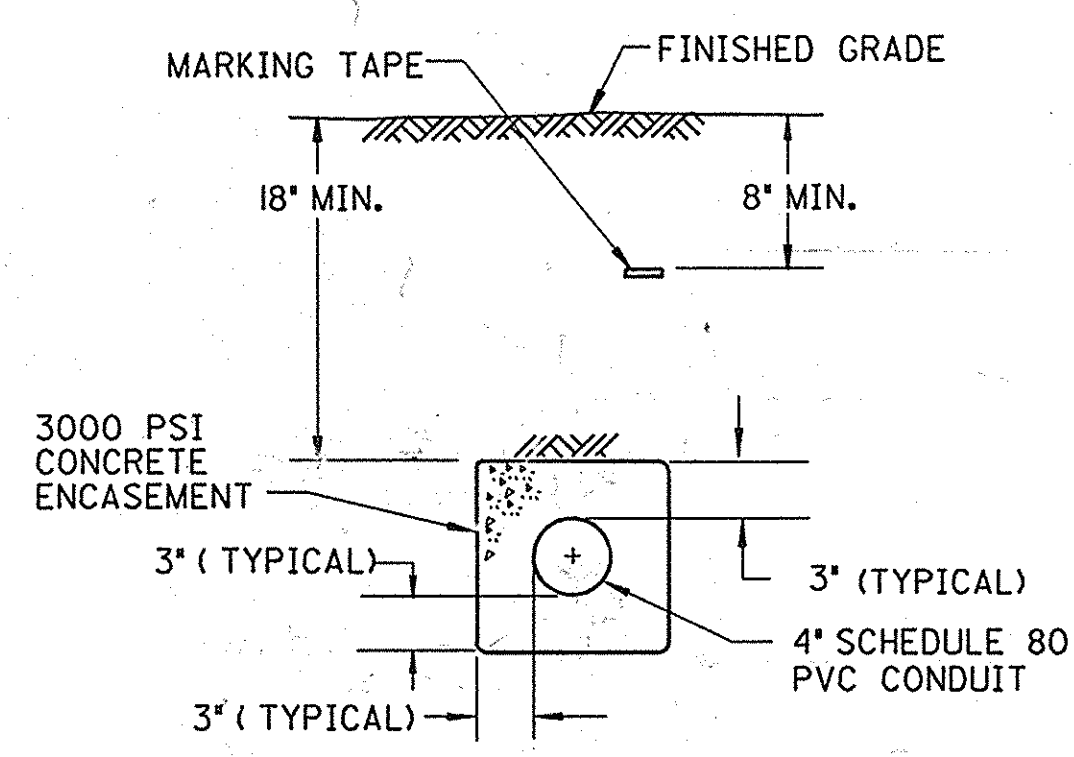

ONE WAY 4" CONCRETE
ENCASED PVC CONDUIT
NOT TO SCALE

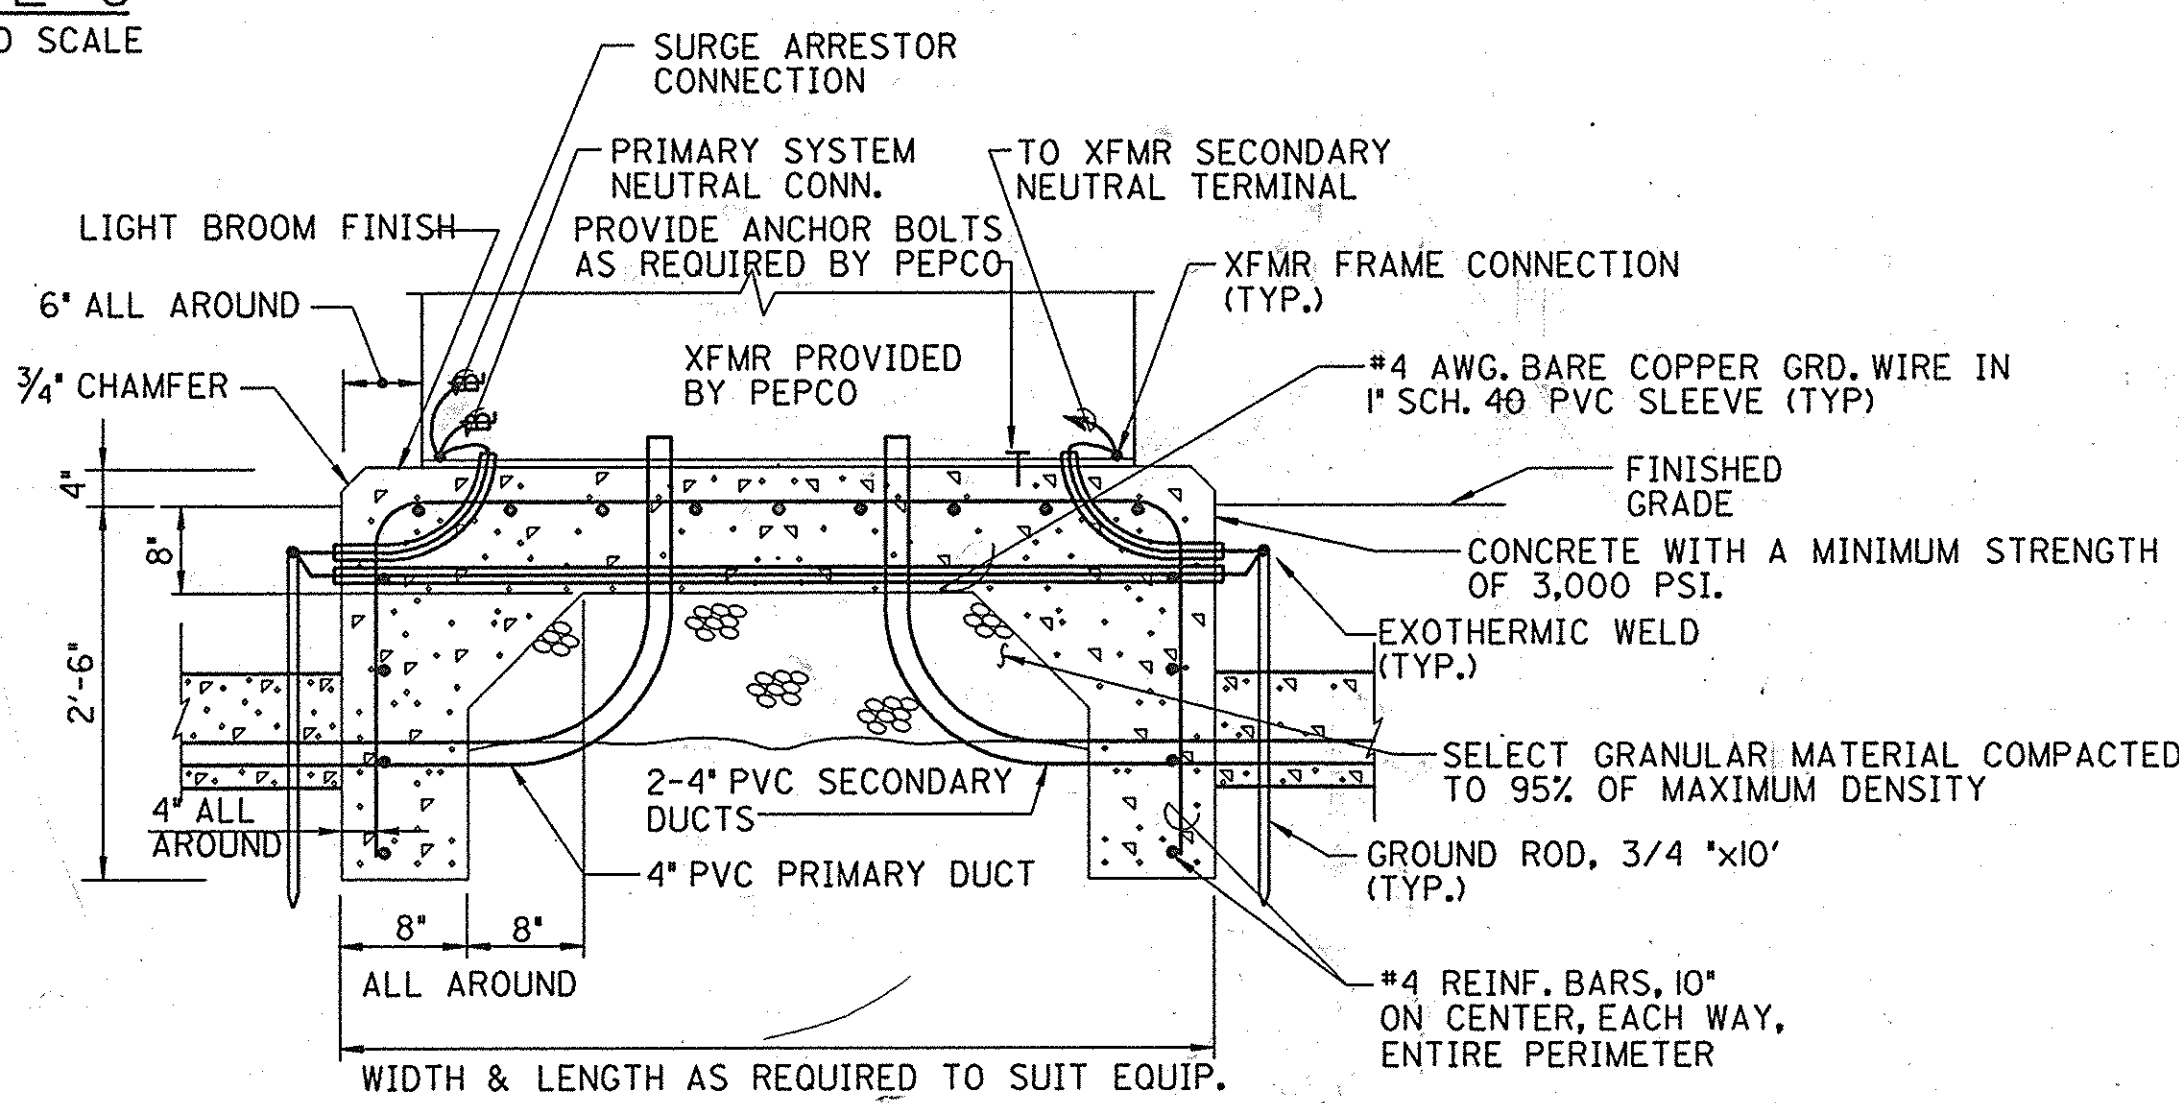

TRANSFORMER PAD DETAIL
NOT TO SCALE

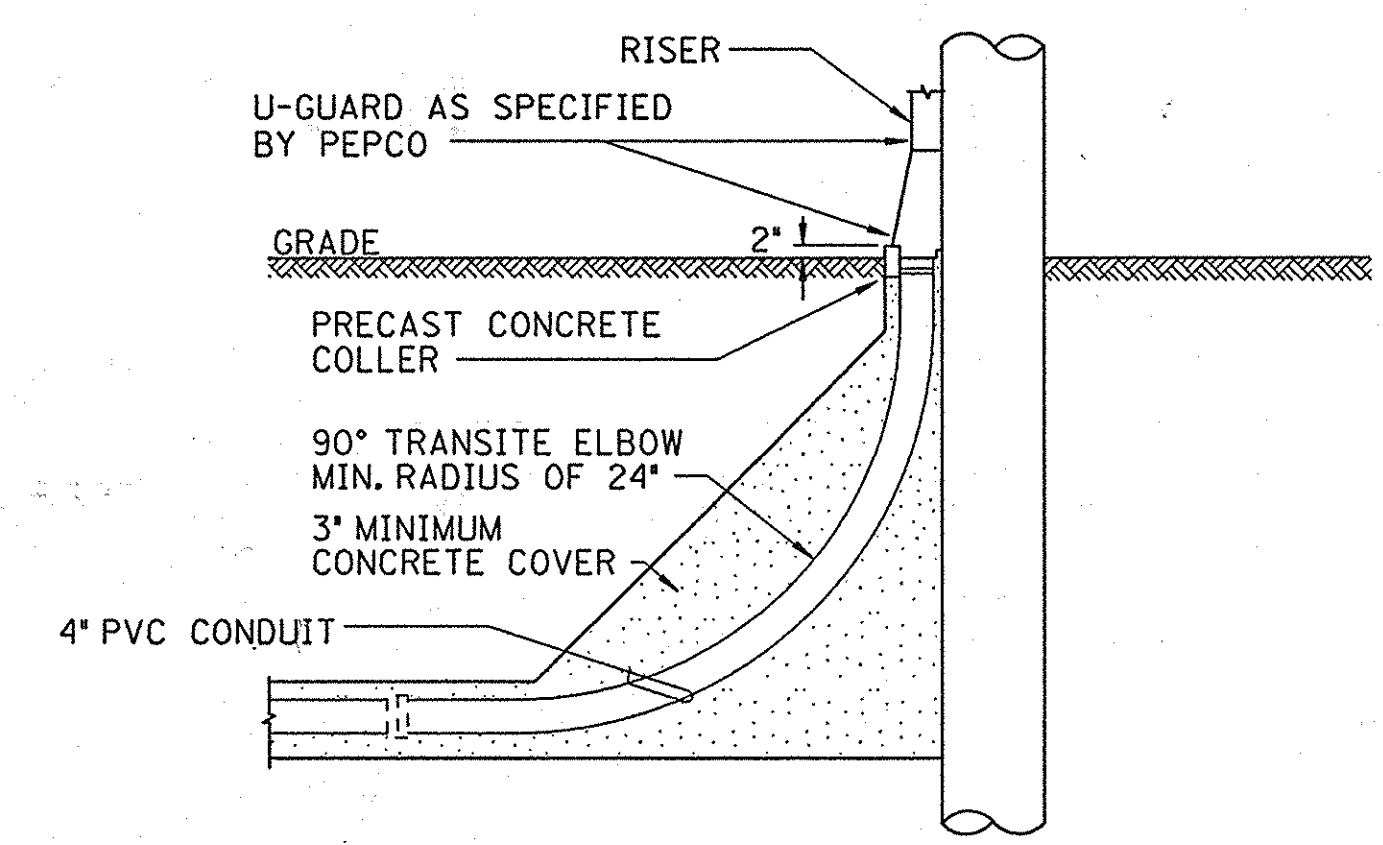

CONDUIT SWEEP DETAIL
PEPCO UTILITY POLES
NOT TO SCALE

KCI TECHNOLOGIES INC. ENGINEERS AND PLANNERS 10 NORTH PARK DRIVE HUNT VALLEY, MARYLAND 21030-1823 (410) 316-7800	REVISIONS	STATE OF MARYLAND DEPARTMENT OF TRANSPORTATION STATE HIGHWAY ADMINISTRATION MD. ROUTE 5 / COVENTRY WAY ELECTRICAL DETAILS	
	CONT. NO. PG3915370 PREL. TRAC. BY	F.A.P. NO. SEE TITLE SHEET FINAL TRAC. BY A.T.C.	SHEET NO. 347 OF 395
	DATE: 09/04/07		